


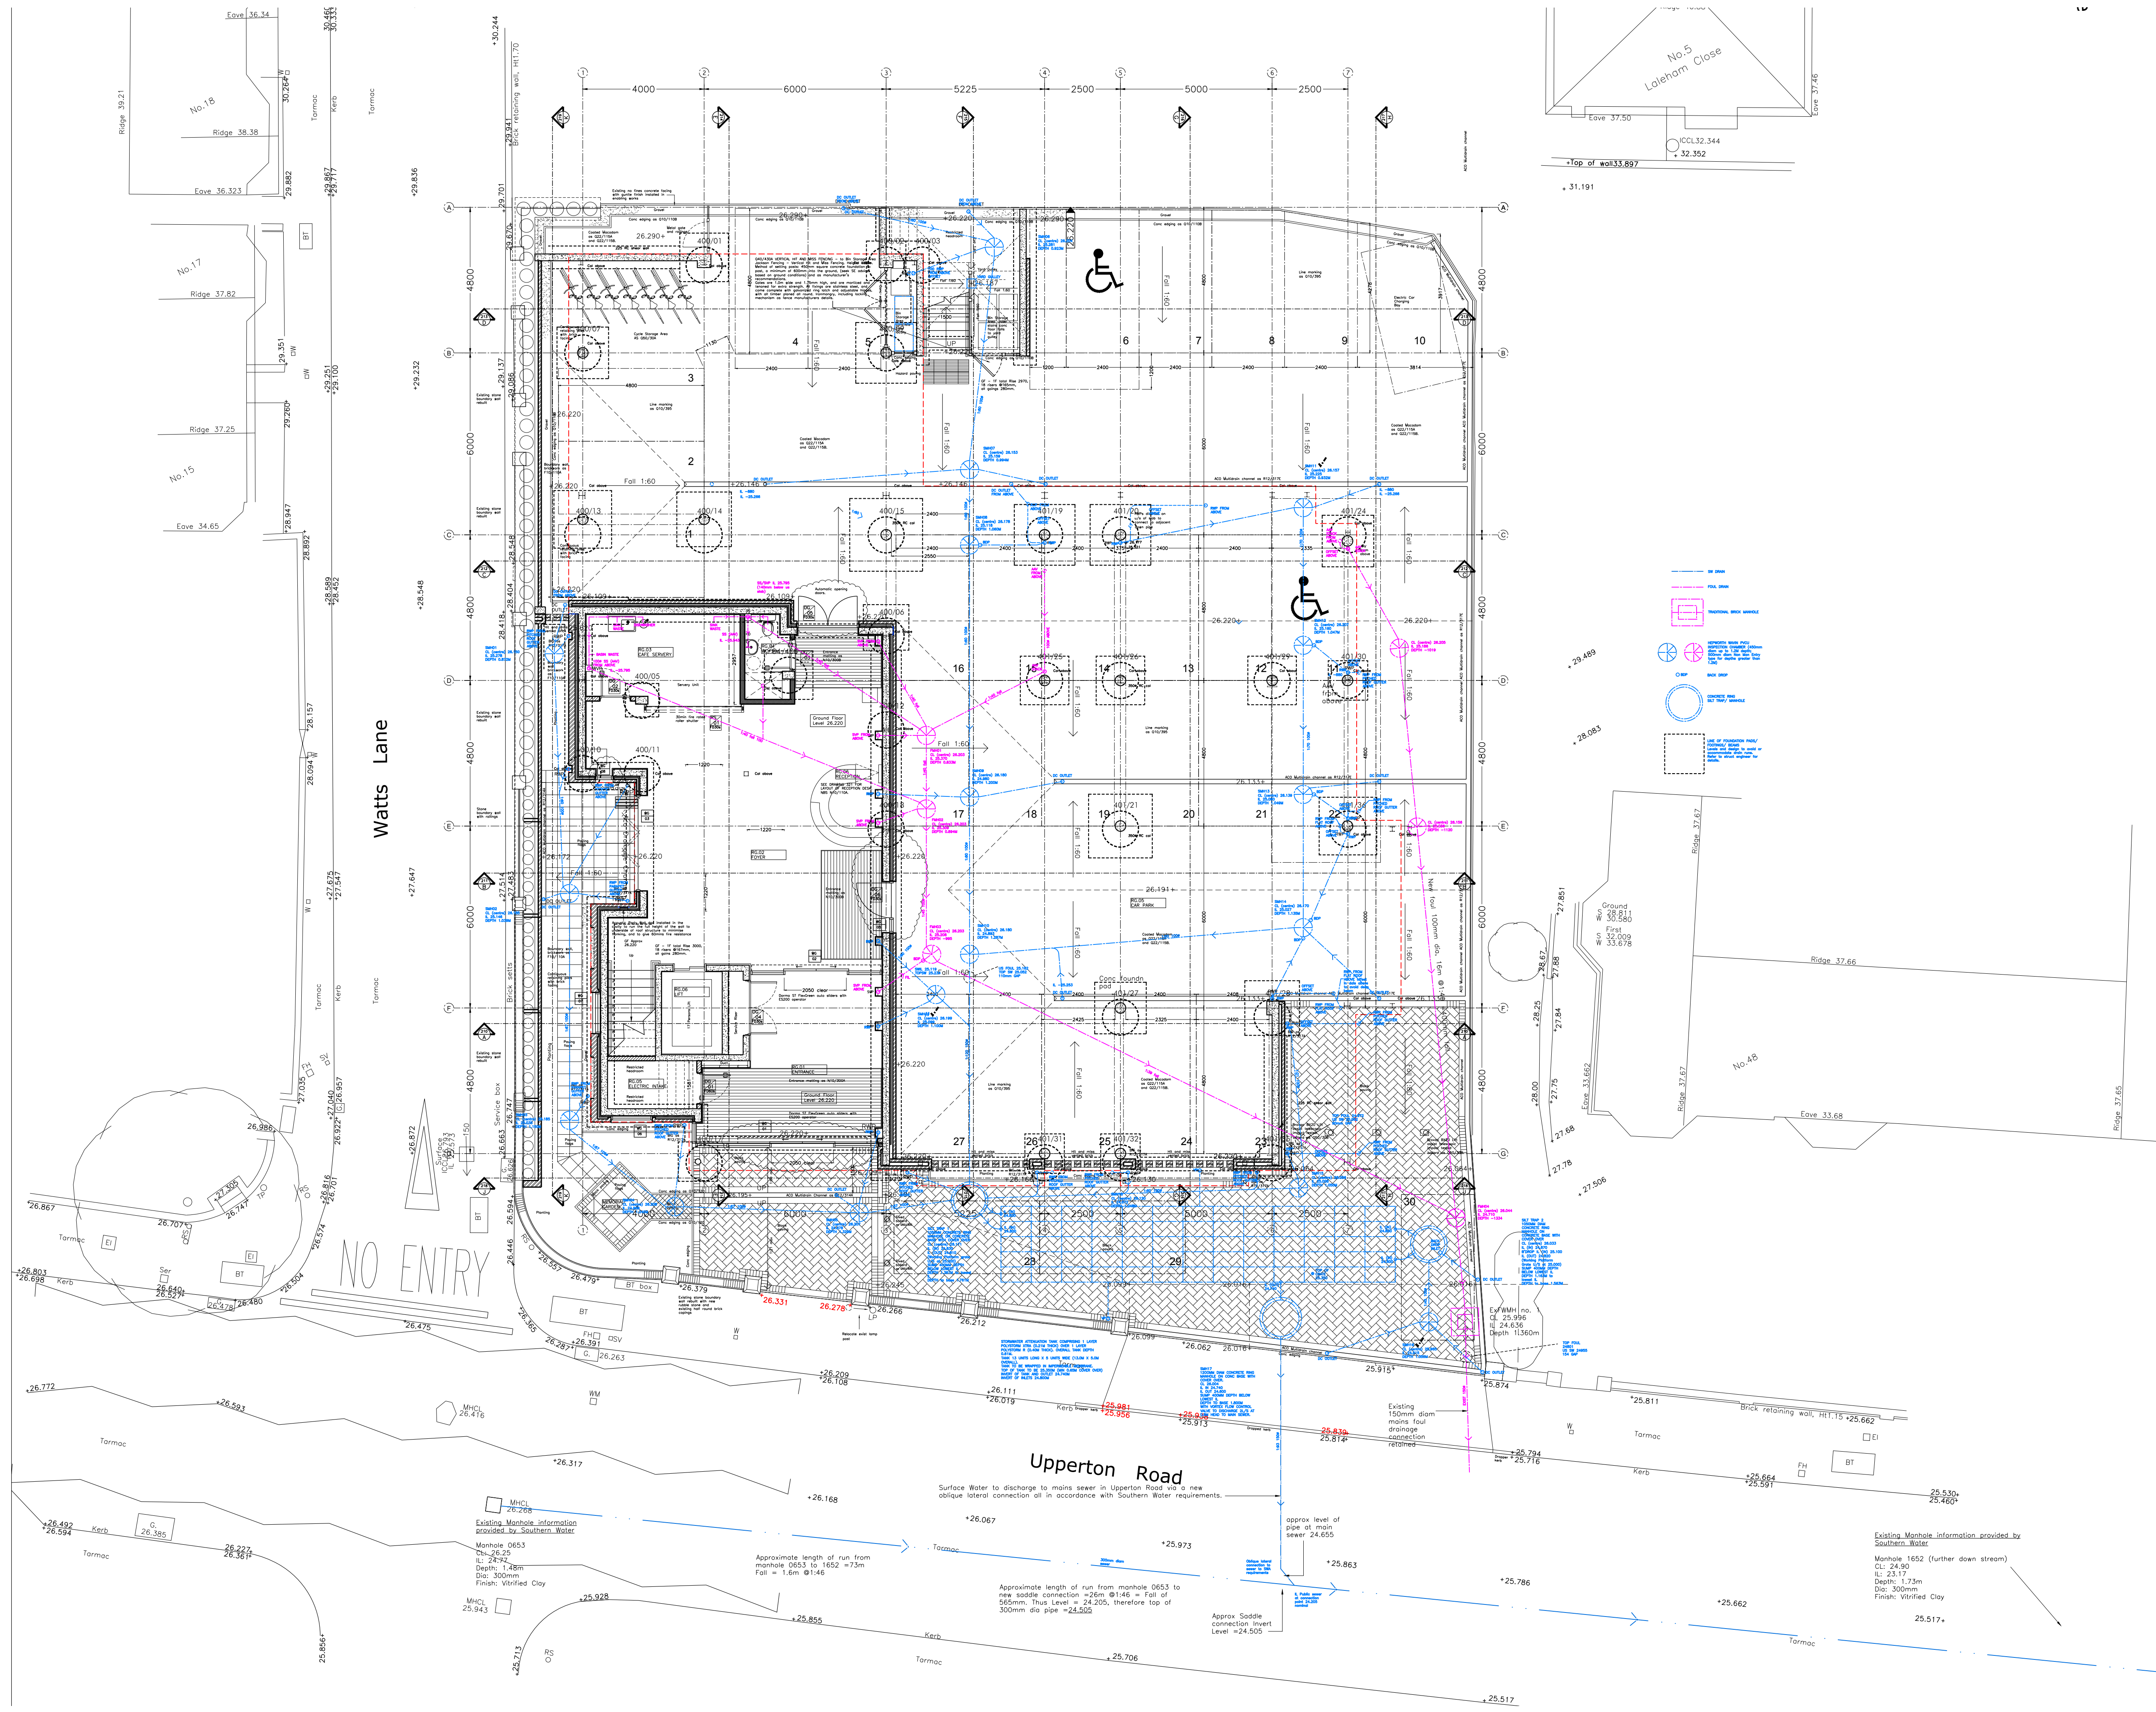

These drawings and designs and the copyright thereof are the property of the Architect and must not be copied or retained without the written permission of the Architect

0 1 2 3 4 5 6 1:100
0 1 2 3 1:50


Rev	Date	Description	Init
P2	31.118	General revision	GL
P4	24.10.18	Major revision following SUDS feedback	GL

- SW DRAIN
- FOUL DRAIN
- TRADITIONAL BRICK MANHOLE
- HEPWORTH WOVEN PVCU INSPECTION CHAMBER (450mm diam up to 1.2m depth; 500mm diam Non Man Entry type for depths greater than 1.2m)
- BDP
- CONCRETE RING SILENCE TRAP/ MANHOLE
- LINE OF FOUNDATION PADS/ FOOTINGS/ BEAMS. Levels and design to avoid or accommodate drain runs. Refer to struct engineer for details.


Chartered Architects, Property Consultants and Designers
Unit A3 Chaux Business park, Dittons Road, Polegate, Sussex BN26 6QH
Tel: 01323 416900 E-mail: admin@cplarchitects.co.uk Web: www.cplarchitects.co.uk

project name
**EMMANUEL CHURCH
UPPERTON ROAD
EASTBOURNE**

drawing title
**PROPOSED GRD FLR
DRAINAGE LAYOUT**

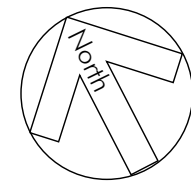	date	scale
	JAN 2017	1:100@A1
	drawn	checked
CLCC		
project number	drawing number	revision
100	1700	01