

KEY

SMOKE DETECTOR

HEAT DETECTOR

NON MAINTAINED EMERGENCY BULKHEAD

CALL POINT

MAINTAINED RUNNING MAN FORWARD

MAINTAINED RUNNING MAN LEFT

MAINTAINED RUNNING MAN RIGHT

CO2 EXTINGUISHER

FOAM EXTINGUISHER

FIRE BLANKET

FIREWALL

LED STRIPLIGHT WITH EMERGENCY BACKUP

EXIT ROUTE

PRINT AT SCALE

1:75 @ ISO A2

V03

10/05/2024

CANTINA

EVOL EMPIRE LIMITED

EASTBOURNE TRAIN STATION

COPYRIGHT NOTICE:

THIS DESIGN IS THE EXCLUSIVE INTELLECTUAL PROPERTY OF THE DESIGNER, JOSHUA CARR. ANY USE OR REPRODUCTION OF THIS DESIGN IS STRICTLY PROHIBITED WITHOUT THE EXPRESS PERMISSION OF THE DESIGNER. THE DESIGNER RESERVES THE RIGHT TO REVOKE PERMISSION AT ANY TIME. UNAUTHORIZED COPYING OR DISTRIBUTION OF THIS DRAWING IS PROHIBITED WITHOUT PRIOR WRITTEN CONSENT FROM THE DESIGNER.

DESIGN CONCEPT DISCLAIMER:

THIS DRAWING REPRESENTS A DESIGN CONCEPT ONLY. ALL ASPECTS OF THE DESIGN MUST BE THOROUGHLY REVIEWED AND VERIFIED BY QUALIFIED CONTRACTORS BEFORE INSTALLATION. COMPLIANCE WITH BUILDING CODES: ALL WORK BASED ON THESE DRAWINGS MUST COMPLY WITH CURRENT BUILDING CODES AND REGULATIONS.

CONSTRUCTION METHODS AND ENGINEERING:

THE SUGGESTED CONSTRUCTION METHODS PROVIDED IN THESE DRAWINGS ARE FOR REFERENCE ONLY. IT IS IMPERATIVE THAT QUALIFIED ENGINEERS AND SPECIALISTS THOROUGHLY REVIEW AND VALIDATE THESE METHODS BEFORE FABRICATION OR INSTALLATION.

NO.	DATE	BY	REVISION NOTES
1	15/04/2024	JC	> VERSION 1 PUBLISHED
2	08/05/2024	JC	> FULL PUBLISH POST ROOF ACCESS. > BAR AND BOOTH DETAIL DRAWINGS
3	16/05/2024	JC	> PLANNING DRAWINGS PUBLISHED

SHEET

FIRE PROTECTION PLAN

SITE INFO

SITE CONTACT

SHOES SIMES

CONTACT NUMBER

07487 6800200

EMAIL

shoes@eatdrinksleep.co.uk

SITE ADDRESS

UNIT 1

EASTBOURNE TRAIN STATION

TERMINUS ROAD

EASTBOURNE

BN21 3QJ

CLIENT INFO

CONTACT NAME

EVOL EMPIRE LIMITED

CONTACT NUMBER

07487 6800200

EMAIL

shoes@eatdrinksleep.co.uk

CLIENT ADDRESS

53 GILDERGE ROAD

EASTBOURNE

BN21 4FS

DESIGNER INFO

SITE CONTACT

JOSHUA CARR DESIGN

CONTACT NUMBER

07717 234666

EMAIL

JOSH.CARR@ME.COM

SITE ADDRESS

1 ST GEORGES RD


HASTINGS

TN34 3NH

ETSB MASTER.vwx

009/1 FIRE PROTECTION GROUND FLOOR  
Scale: 1:75

009/2 FIRE PROTECTION FIRST FLOOR  
Scale: 1:75

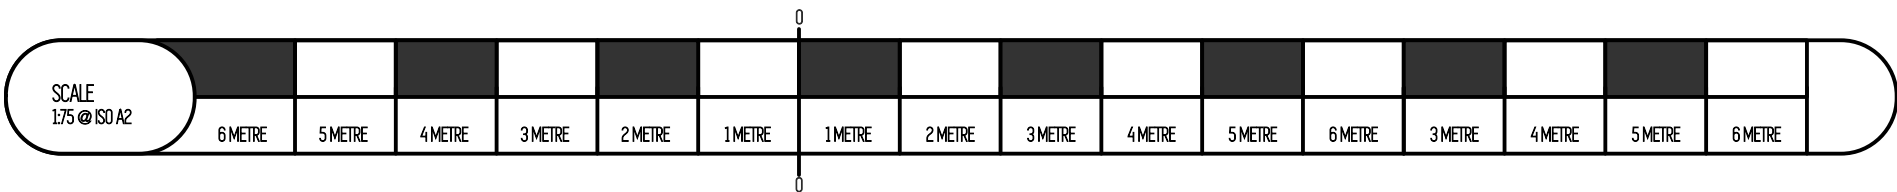

FOR PLANNING